
 




HARDWIRED AND INTERCONNECTED
SMOKE ALARM

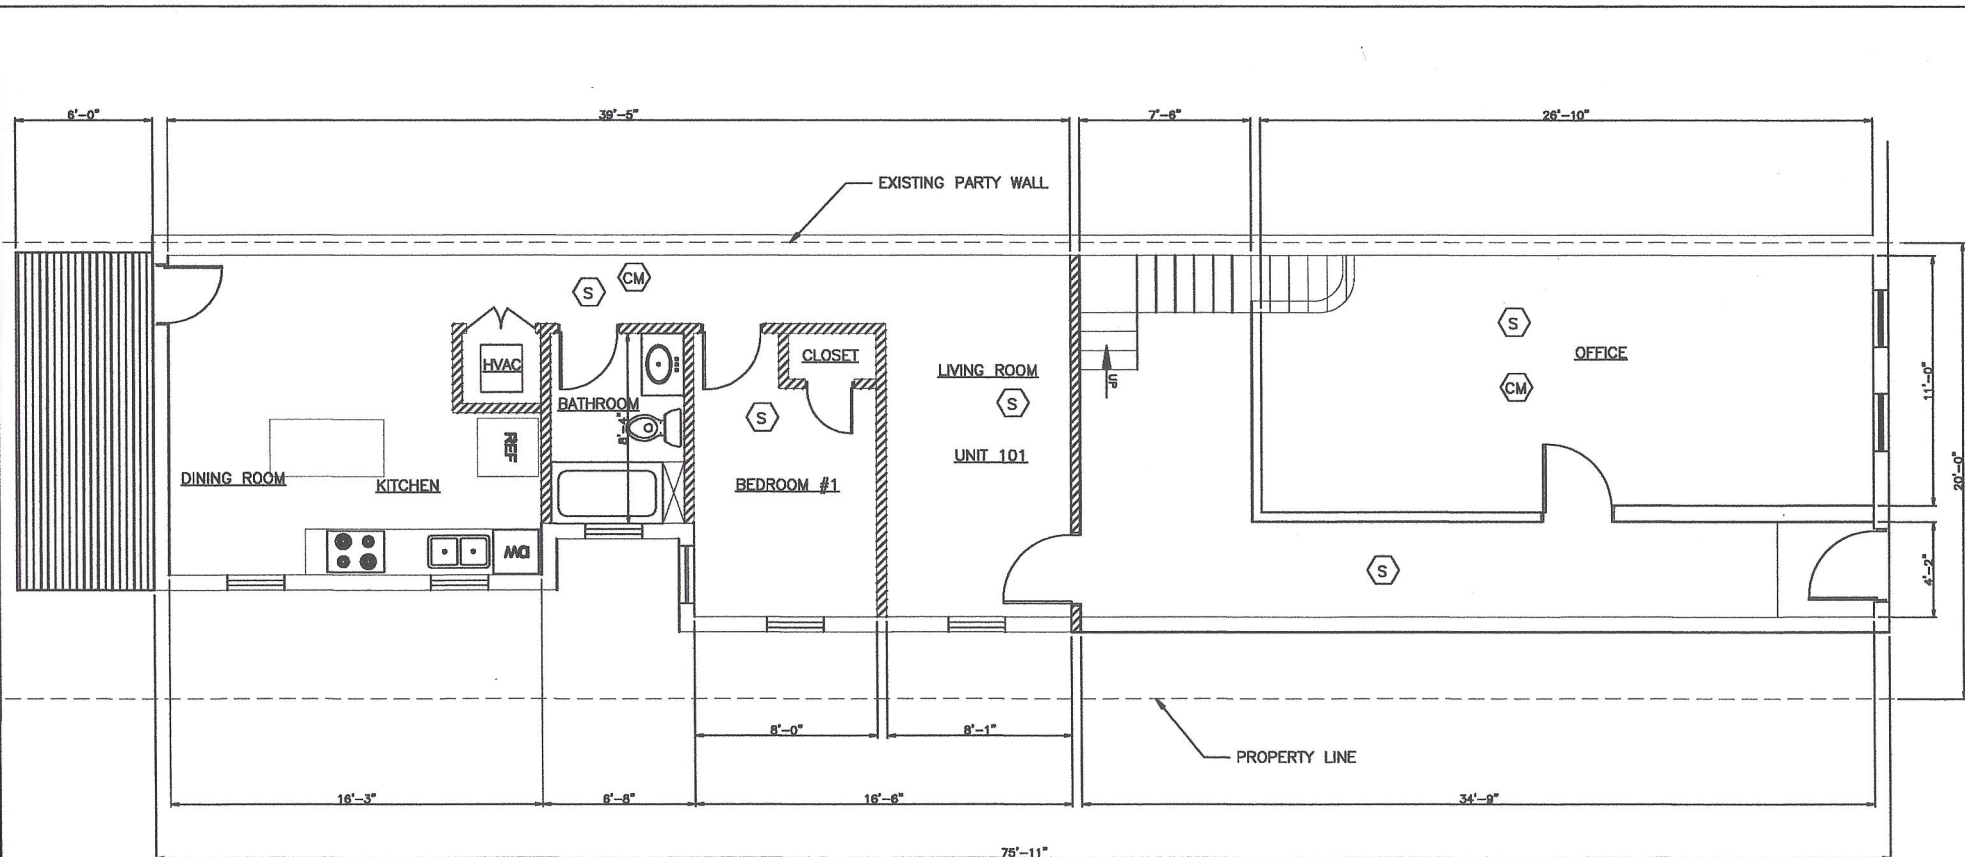

HARDWIRED AND INTERCONNECTED
CARBON MONOXIDE
ALARM -UL 2034



FIRST FLOOR PLAN

SCALE: 3/16" = 1'-0"

PROFESSIONAL CERTIFICATION: I HEREBY CERTIFY THAT THESE DOCUMENTS WERE PREPARED OR APPROVED BY ME, AND THAT I AM A DULY LICENSED PROFESSIONAL ENGINEER UNDER THE LAWS OF THE STATE OF MARYLAND, LICENSE NO. 23081 EXPIRATION DATE: 04/24/2021

724 N CARROLLTON AVE
BALTIMORE MD, 21217

A1

RENOVATION


FIRST FLOOR PLAN

SCALE AS SHOWN	WORK REQUEST # 20-239	SHEET 01 OF 03	DRAWING NO. 20-239-01
-------------------	--------------------------	-------------------	--------------------------

FORM 10-13-17

FILE DATE

FILE NAME

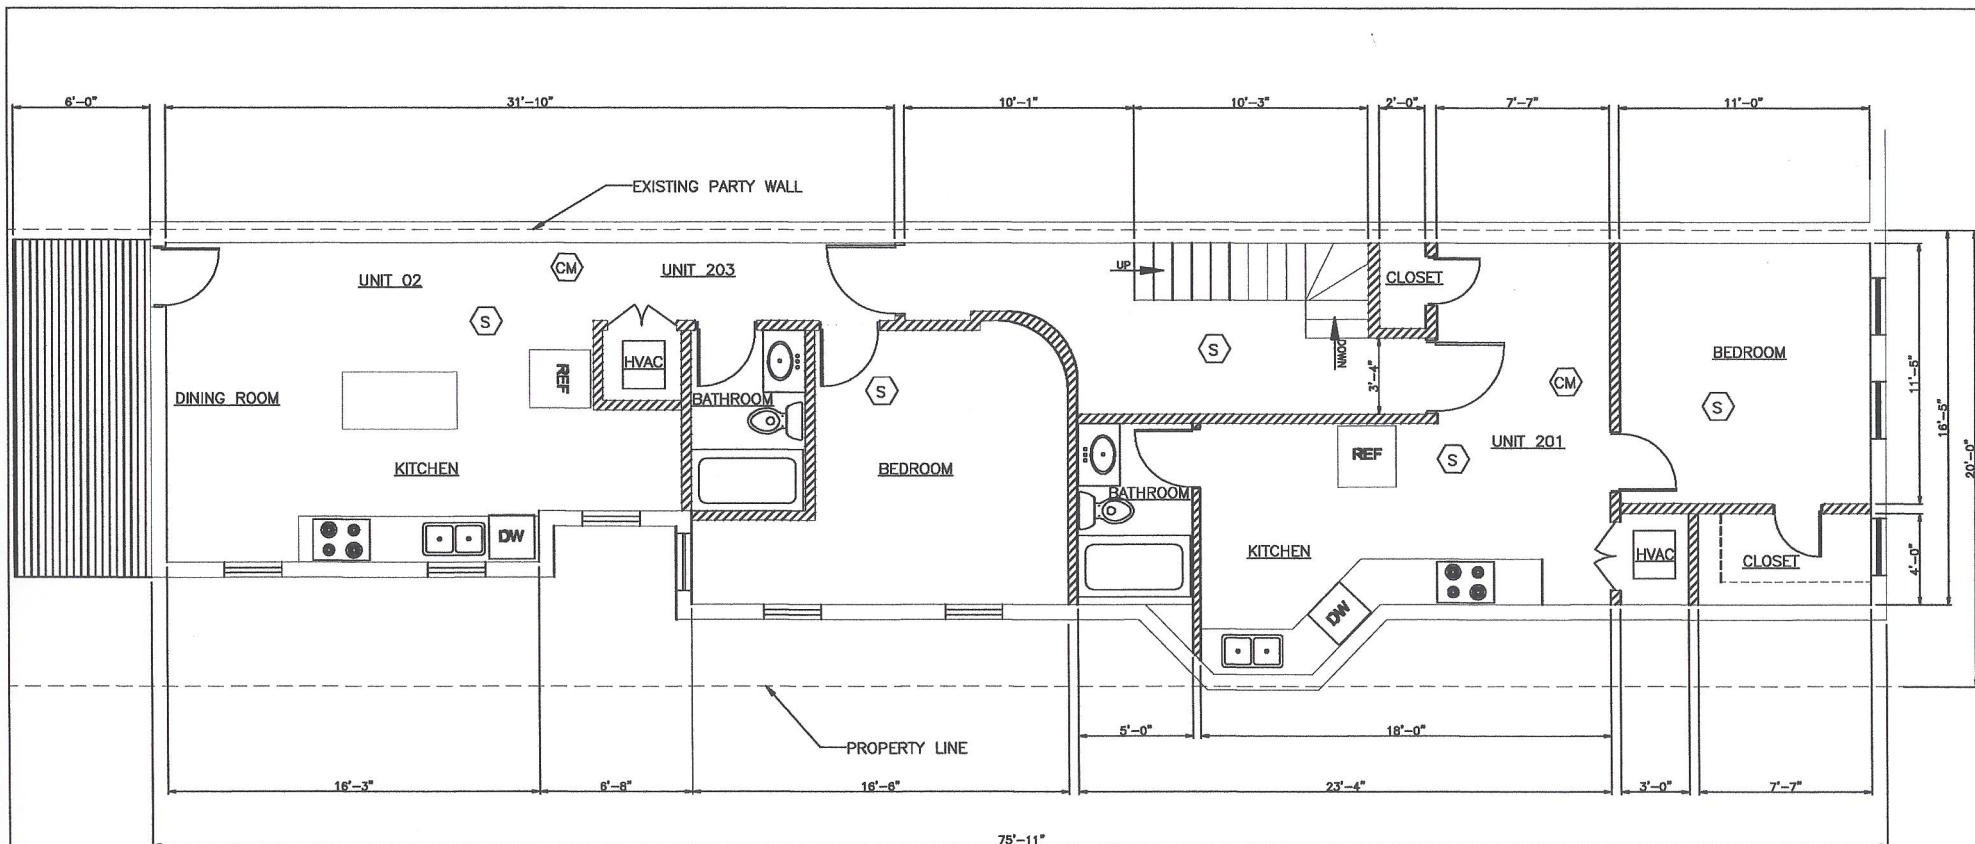

HARDWIRED AND INTERCONNECTED
SMOKE ALARM



HARDWIRED AND INTERCONNECTED
CARBON MONOXIDE
ALARM -UL 2034



SECOND FLOOR PLAN

SCALE: 3/16" = 1'-0"

PROFESSIONAL CERTIFICATION: I HEREBY CERTIFY THAT THESE DOCUMENTS WERE PREPARED OR APPROVED BY ME, AND THAT I AM A DULY LICENSED PROFESSIONAL ENGINEER UNDER THE LAWS OF THE STATE OF MARYLAND, LICENSE NO. 23081 EXPIRATION DATE: 04/24/2021

724 N CARROLLTON AVE

BALTIMORE MD, 21217

RENOVATION

SECOND FLOOR PLAN


A2

SCALE AS SHOWN	WORK REQUEST # 20-239	SHEET 02 OF 03	DRAWING NO. 20-239-02
-------------------	--------------------------	-------------------	--------------------------

FORM 10-23-07

FILE DATE


FILE NAME

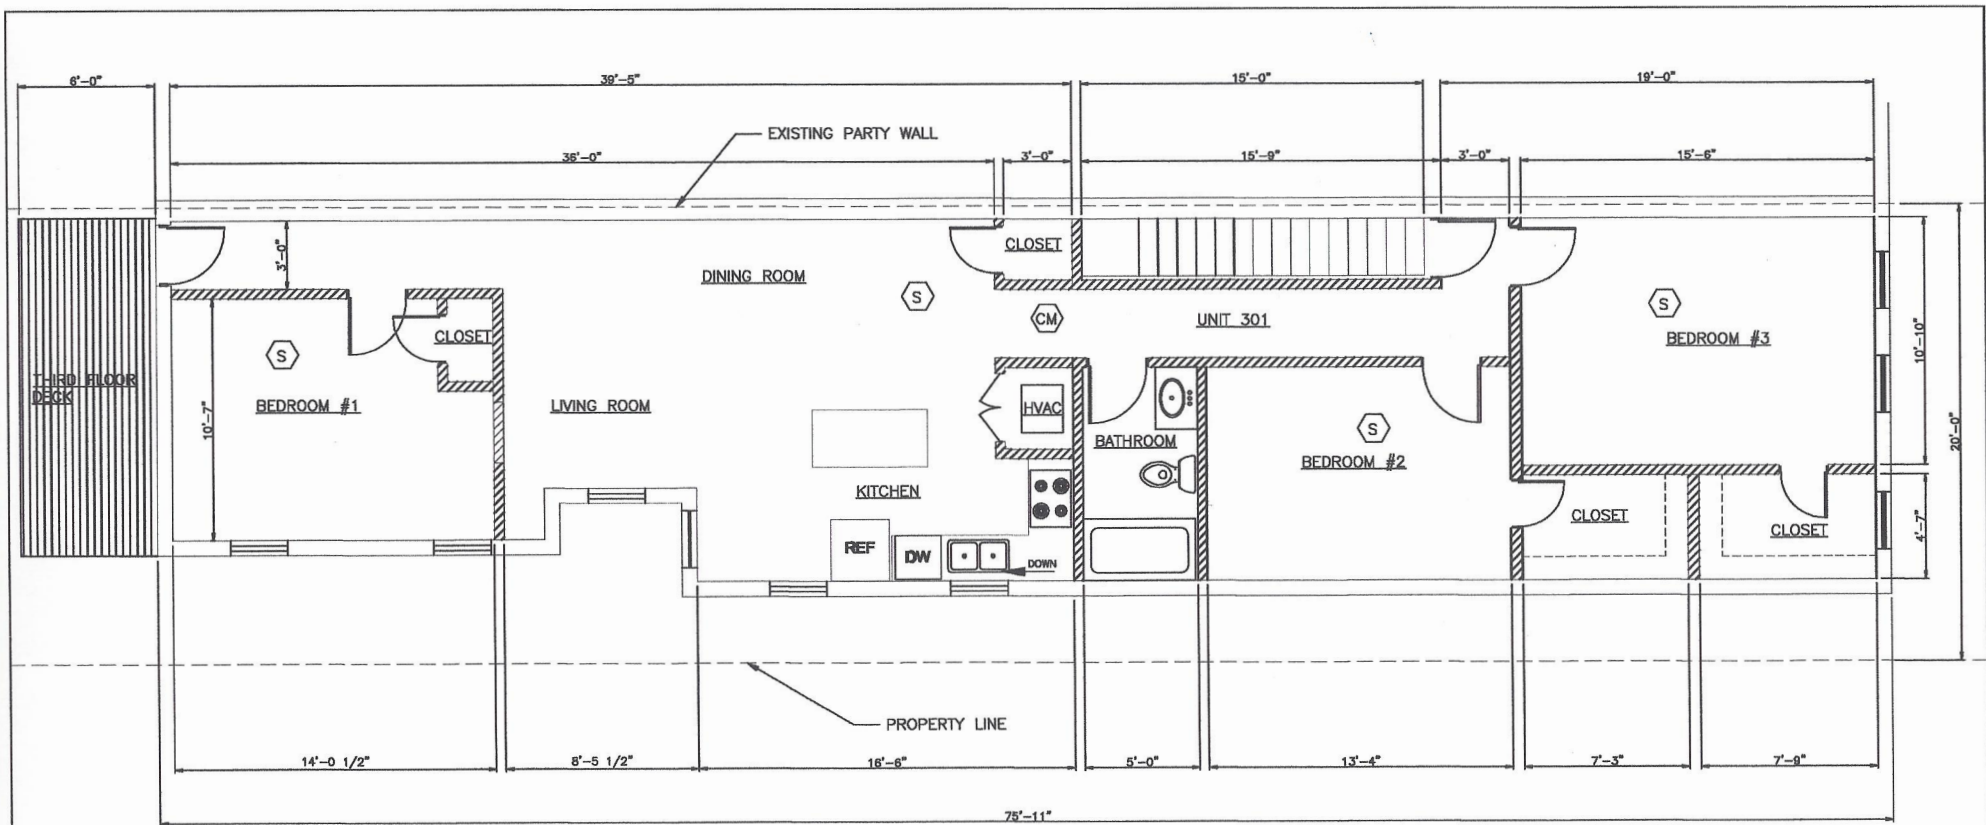

HARDWIRED AND INTERCONNECTED
SMOKE ALARM



 HARDWIRED AND INTERCONNECTED
CARBON MONOXIDE
ALARM —UL 2034



THIRD FLOOR PLAN

SCALE: 3/16" = 1'-0"

PROFESSIONAL CERTIFICATION: I HEREBY CERTIFY THAT THESE DOCUMENTS WERE PREPARED OR APPROVED BY ME, AND THAT I AM A DULY LICENSED PROFESSIONAL ENGINEER UNDER THE LAWS OF THE STATE OF MARYLAND, LICENSE NO. 23081 EXPIRATION DATE: 04/24/2021

724 N CARROLLTON AVE BALTIMORE MD, 21217 RENOVATION		A3	
THIRD FLOOR PLAN			
SCALE AS SHOWN	WORK REQUEST # 20-239	SHEET 03 OF 03	DRAWING NO. 20-239-03

FILE DATE: FILE NAME: